


- KEYED NOTES:**
- ① SUPPLY GRILLE SS, 12 X 12, 500 CFM.
 - ② RETURN GRILLE RR, 20 X 30, 1500 CFM.
 - ③ RETURN GRILLE RR, 12 X 16, 500 CFM.
 - ④ SUPPLY DIFFUSER, SS-4, 12 X 12, 300 CFM.
 - ⑤ RETURN GRILLE, RS, 14 X 14, 600 CFM.

**MECHANICAL -
CENTRAL ENERGY PLANT FLOOR PLAN**
SCALE: 1/8" = 1'-0"



1

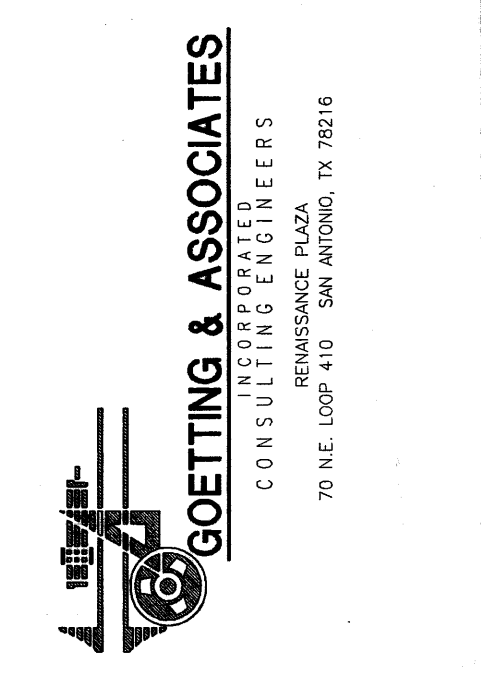

Revisions

RECORD DRAWING	04/05/96

FORD, POWELL & CARSON, INC.
JONES & KELL INC.
Joint Venture Architects

1108 East Commerce Street / San Antonio, Texas 78205 / 210-289-1246 / fax 210-289-4482



LAREDO STATE UNIVERSITY
CAMPUS FACILITIES
PHASE ONE

Job No. #16-2729
TAMUS #16-2729
FPC/JK JV: #54501

**MECHANICAL - FLOOR PLANS
CENTRAL ENERGY PLANT**

Checked By SAK

Drawn By DJK

Date 07/25/1993

Sheet No.

M4.16
of 52

RECORD DRAWING
DATE: 04/05/96
These Record Drawings have been prepared, in part, on the basis of information compiled and furnished by others. The Architect/Engineer cannot assume its occupancy, and therefore cannot be responsible for any errors or omissions which have been incorporated into this document as a result.