


1 BUILDING-H LEVEL-1 MECHANICAL PLAN
SCALE: 1/8" = 1'-0"

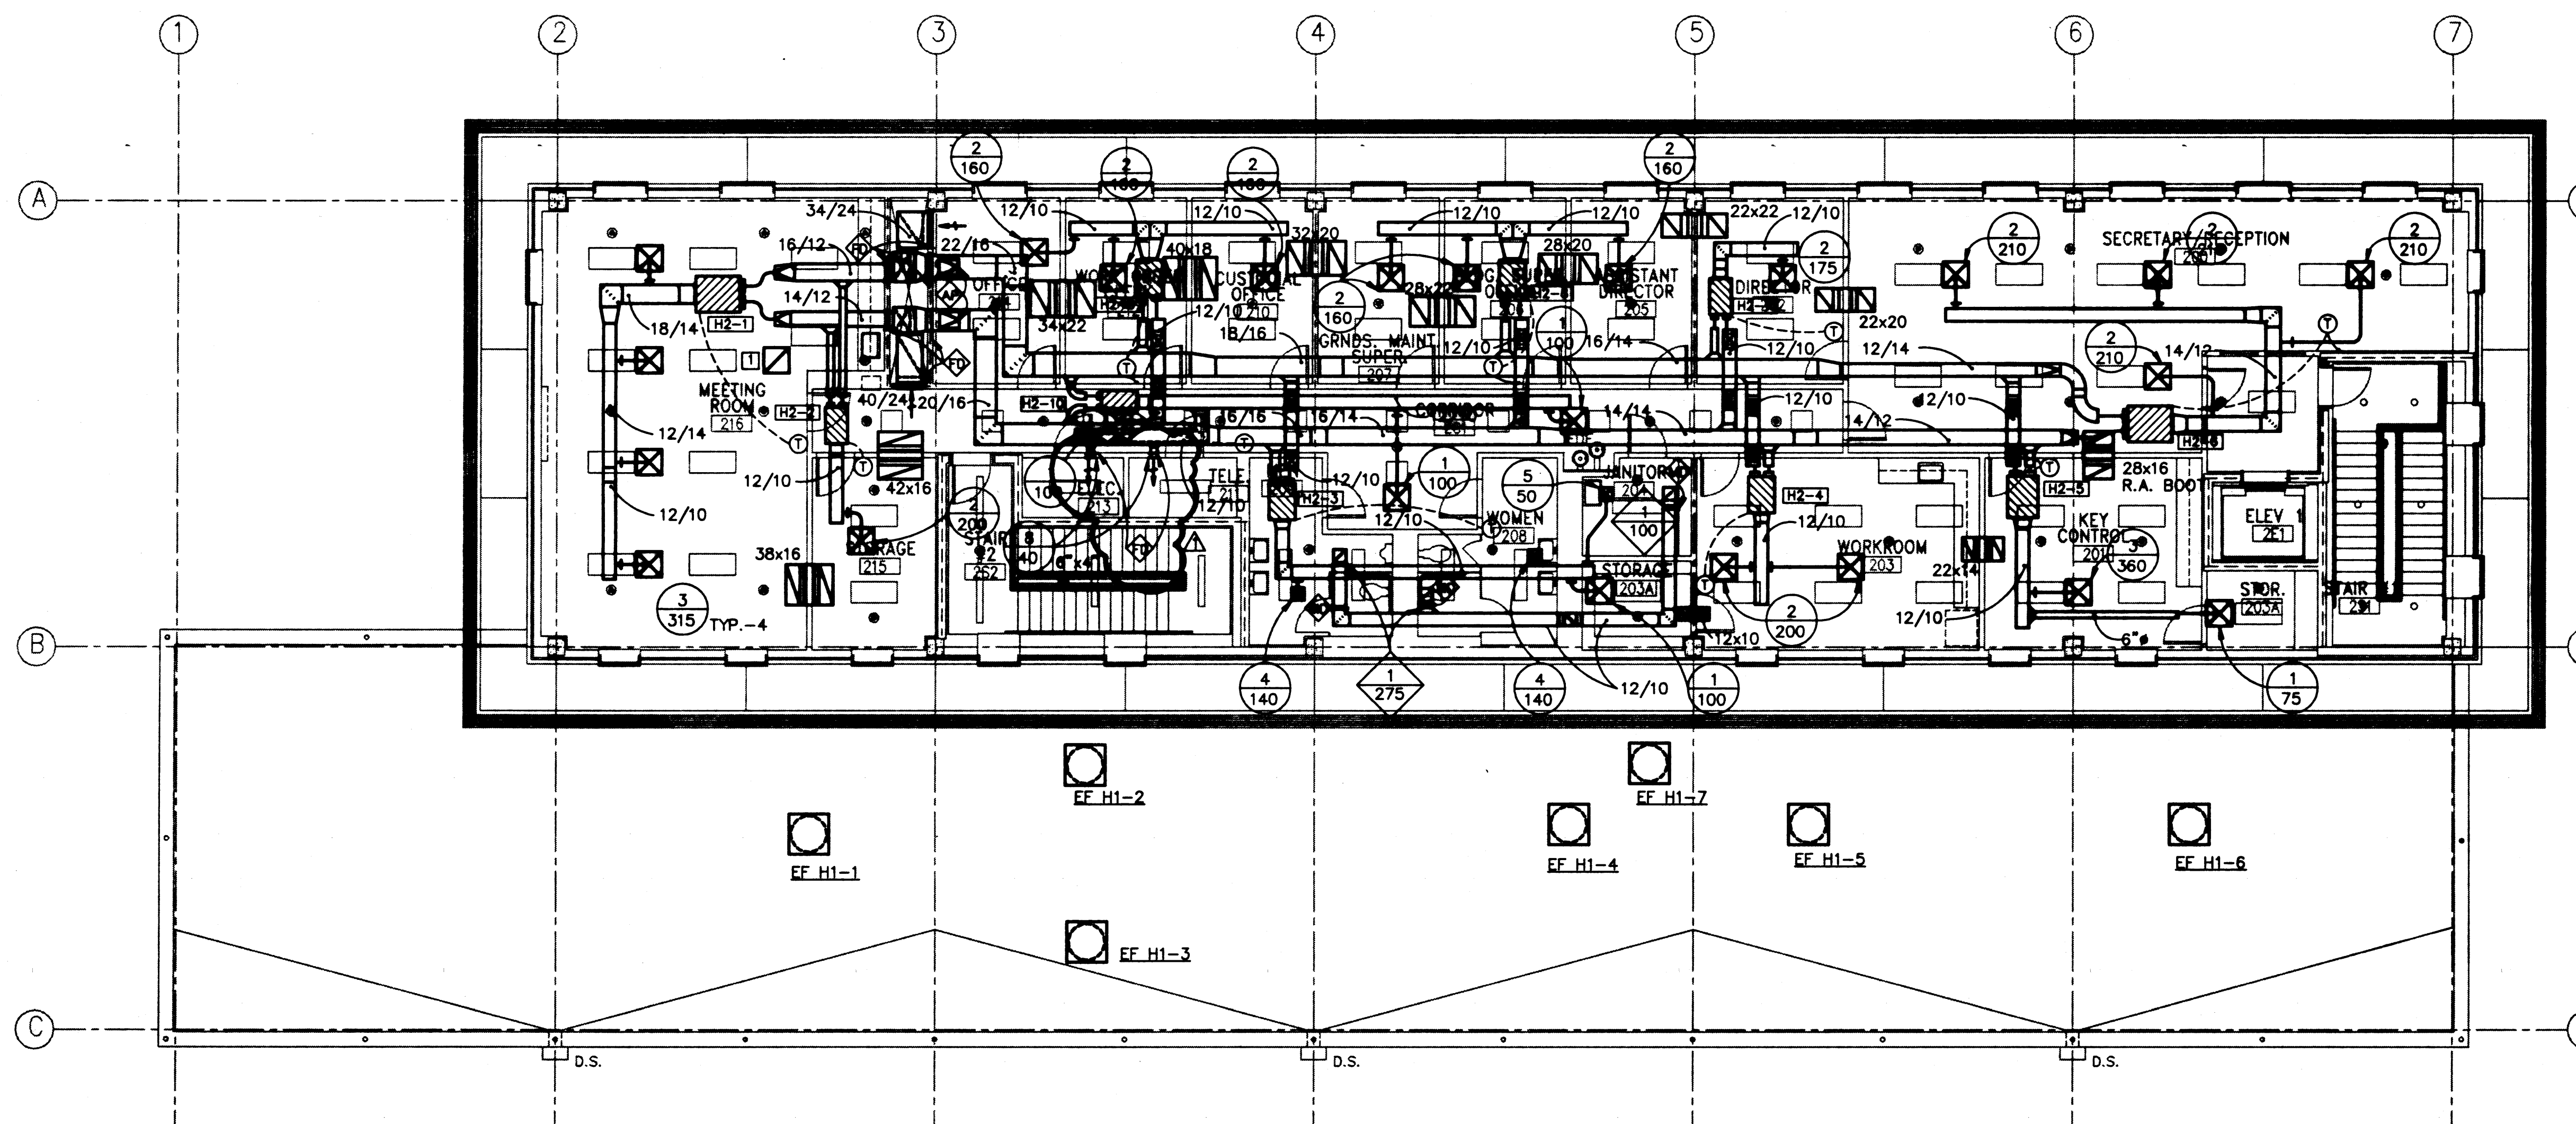

2 BUILDING-H LEVEL-2 MECHANICAL PLAN
SCALE: 1/8" = 1'-0"

RECORD DRAWING
DATE: MAY 1, 1997
These Record Drawings have been prepared in part on the basis of information compiled and furnished by others. The Architect/Engineer cannot assume accuracy, and therefore cannot be responsible for any errors or omissions which have been incorporated into this document as a result.

KEYPLAN	

RECORD JOB No. 180000

Revisions
RECORD DWG. REVISION
MAY 1, 1997

KELL MUÑOZ WIGODSKY, INC.
FORD, POWELL & CARSON, INC.
Joint Venture Architects
118 East Commerce Street / Ste. 2000 / Austin, Texas 78701 / Tel: 512-477-1999 / Fax: 512-477-9999

TEXAS A&M INTERNATIONAL UNIVERSITY
CAMPUS FACILITIES
PHASE TWO

BUILDING - H
MECHANICAL
FLOOR PLANS

Checked By **DLN**
Drawn By **AMS**
Date **02/19/95**
Job No. **TAMU 18-2764**
KRM/PPC JV #64891
Sheet No.
M-111
of 37